

NOTE: CONFIDENTIAL NO THIRD PARTY DISCLOSURE ALLOWED
 All rights reserved.
 J.B. Barry and Partners
 T.J. O'Connor and Associates
 Royal HaskoningDHV 2014

1. All levels are in metres and relate to O.S. Datum MALIN.
 2. This drawing is reproduced from digital maps:
 O.S. MAPS - Scale 1:2500
 O.S. MAPS - Scale 1:5000
 Discovery Series - Scale 1:50,000
 3. All Maps are referenced to IRISH NATIONAL GRID (I.T.M.)
 4. Reproduced from the Ordnance Survey of Ireland by Permission of the Government. License No. 3-1-34.

- LEGEND:**
- SITE DEVELOPMENT BOUNDARY
 - BOUNDARY WALL (TYPE 1)
 - CHAINLINK FENCING (TYPE 2)
 - PALISADE FENCING (TYPE 3)
 - EXISTING ROADS & FOOTPATH
 - PROPOSED PLANTING
 - MANHOLE
 - FS — PROPOSED FOUL SEWER
 - FS — EXISTING FOUL SEWER
 - EXISTING FOUL RISING MAIN
 - SECTION OF EXISTING FOUL DRAINAGE TO BE REMOVED

TOWNLAND OF NEWTOWN


PROPOSED HGV CLEANING AREA (REFER TO TYPICAL DETAILING ON Y17702-PL-024)

REFER TO 17702-PL-008 & Y17702-PL-010 FOR INTERNAL FLOOR GRADIENTS

MAINTAIN OUTFALL CONNECTION TO SEWER

FOUL DRAINAGE PIPE FROM ADJOINING PROPERTY UNDER CONSTRUCTION

FOUL PUMPING STATION (REFER TO Y17702-PL-018)

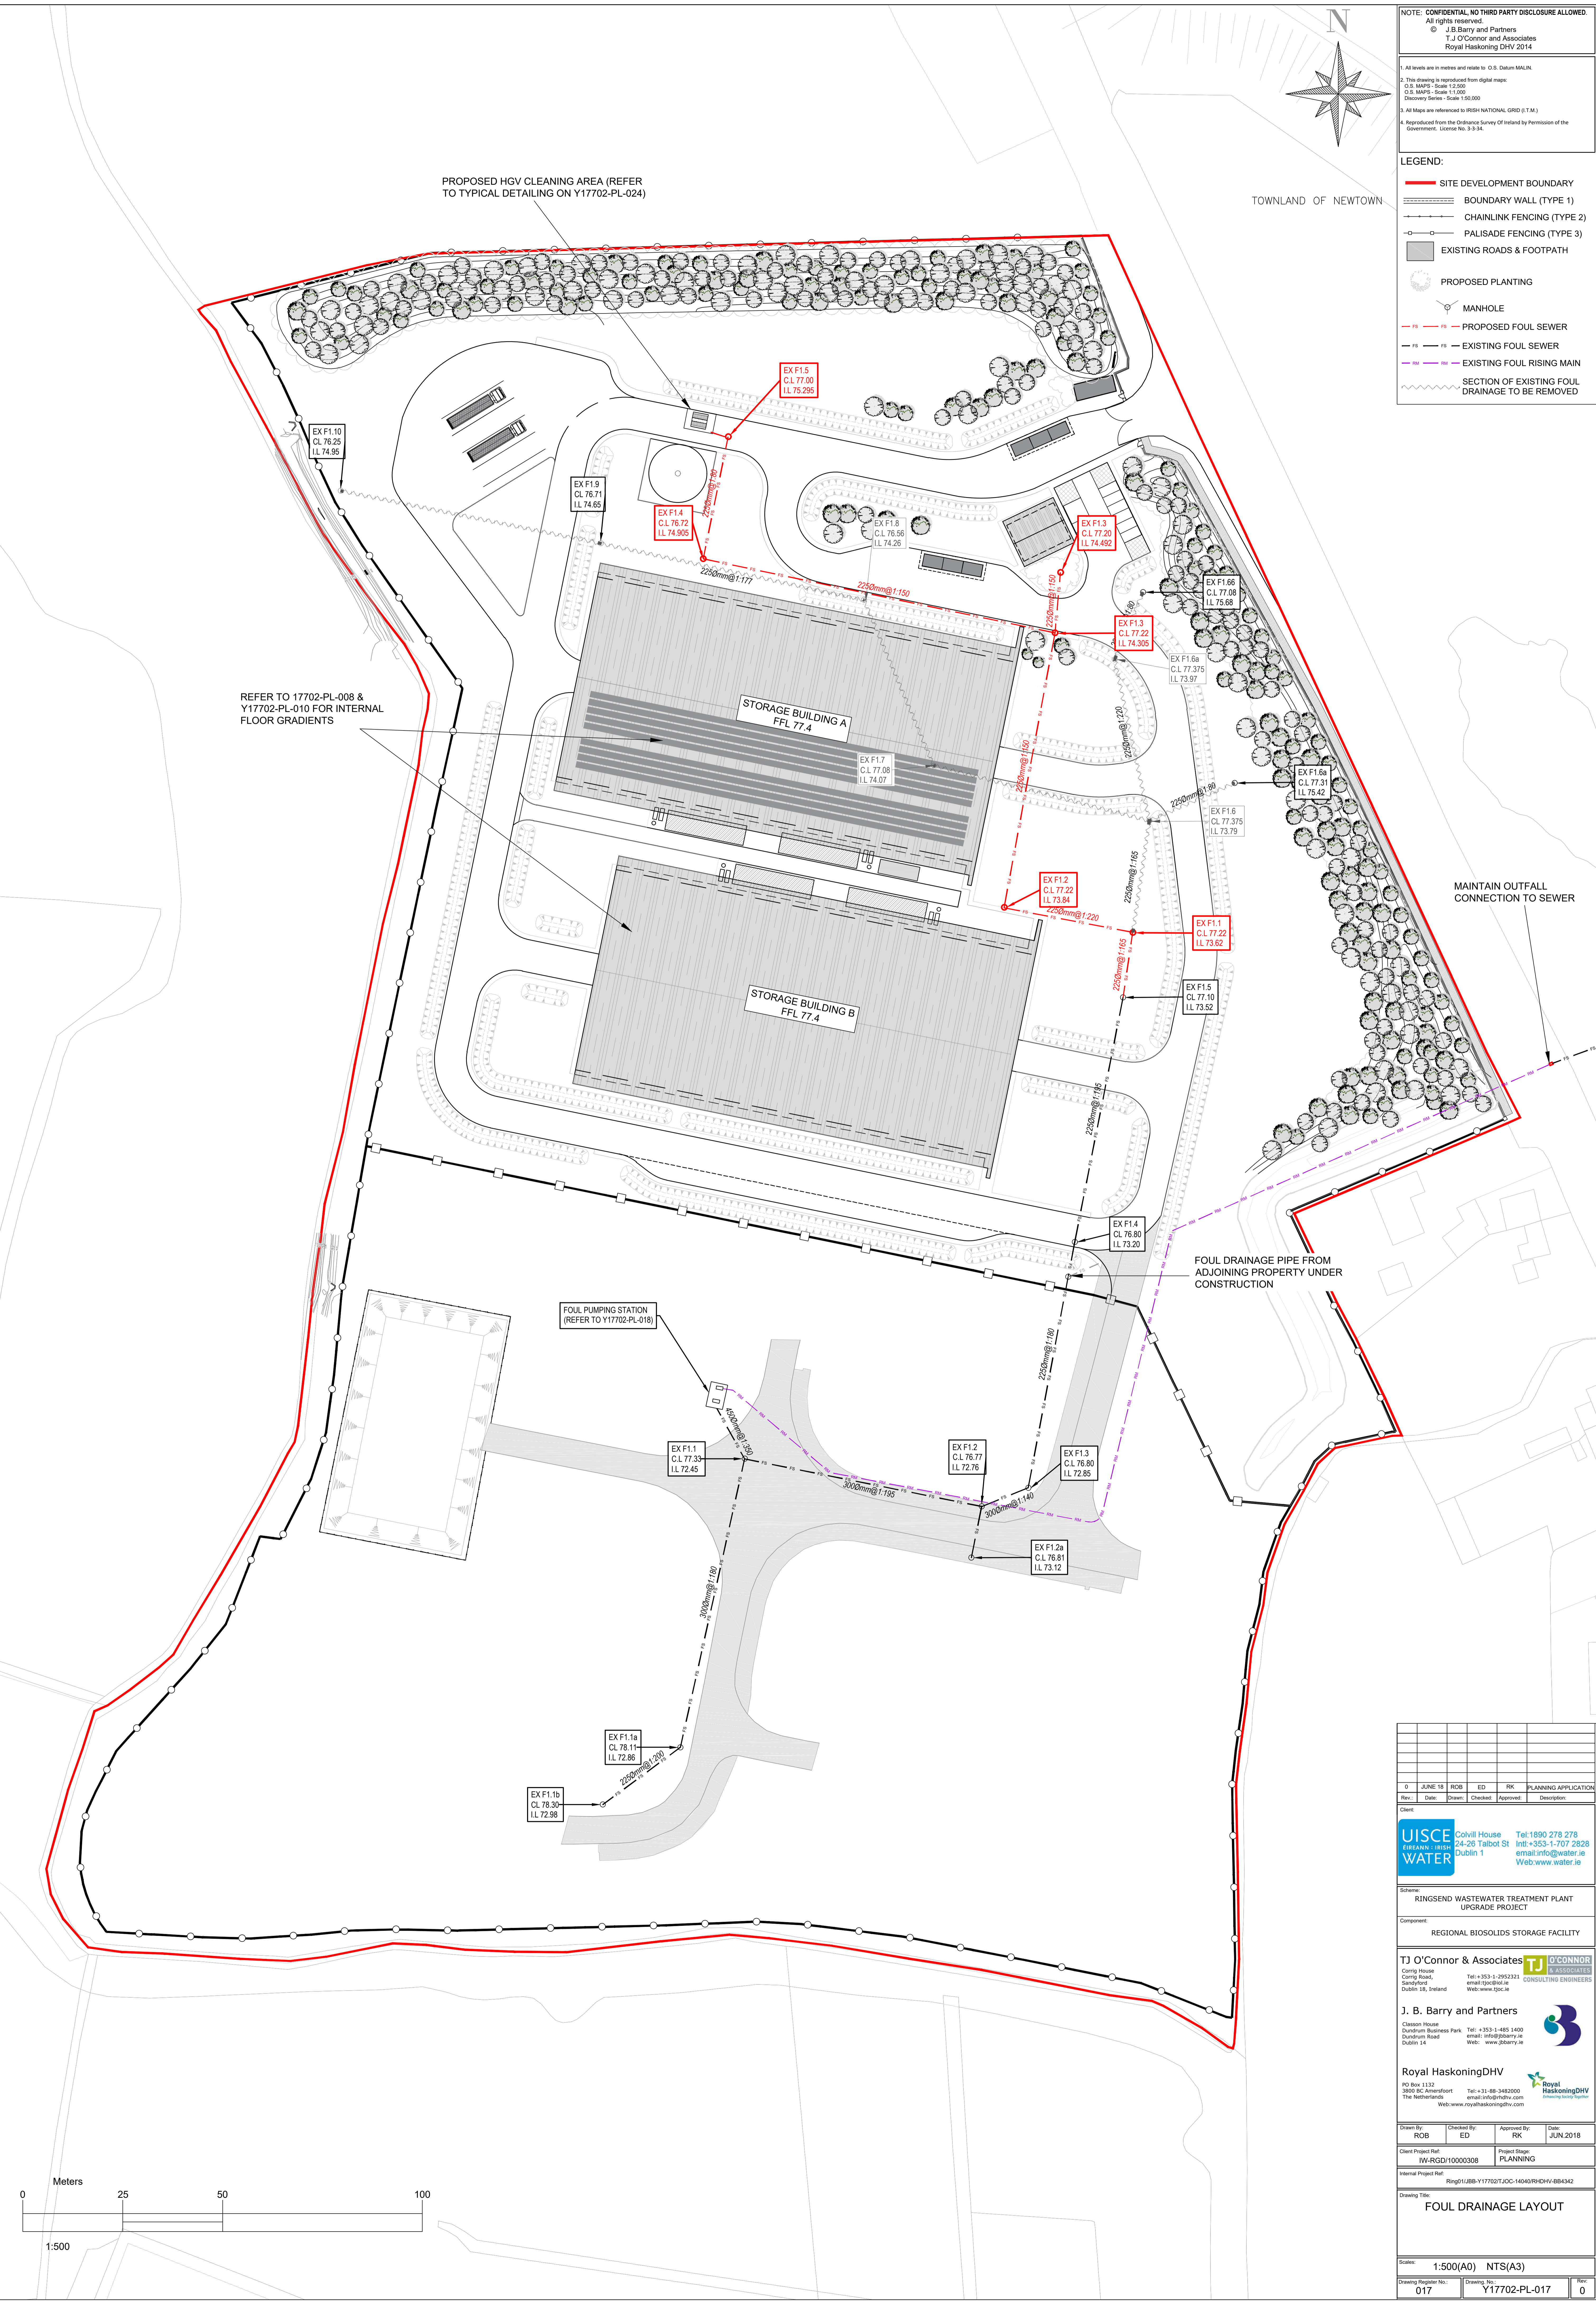

Rev.	Date	Drawn	Checked	Approved	Description
0	JUNE 18	ROB	ED	RK	PLANNING APPLICATION

Client:
UISCE WATER Colville House Tel: 1890 278 278
 24-26 Talbot St Int: +353-1-707 2528
 Dublin 1 email: info@uisce.ie
 Web: www.uisce.ie

Scheme:
 RINGSSEND WASTEWATER TREATMENT PLANT UPGRADE PROJECT
 Component:
 REGIONAL BIOSOLIDS STORAGE FACILITY

TJ O'Connor & Associates CONSULTING ENGINEERS
 Conry Road, Tel: +353-1-2952321
 Sandymount, email: info@tjoc.ie
 Dublin 18, Ireland Web: www.tjoc.ie

J. B. Barry and Partners
 Clason House Tel: +353-1-485 1400
 Dundrum Business Park, email: info@jbarry.ie
 Dundrum Road, Dublin 14 Web: www.jbarry.ie

Royal HaskoningDHV
 PO Box 2132 Tel: +31-88-3482000
 3800 KC Amersfoort, email: info@rhdhv.com
 The Netherlands Web: www.royalhaskoningdhv.com

Drawn By:	ROB	Checked By:	ED	Approved By:	RK	Date:	JUN 2018
Client Project Ref:	RW-RGD/10000308	Project Stage:	PLANNING				
Internal Project Ref:	Ring01/BB-Y17702/JOC-14040/RH/DHV-BB4342						

Drawing Title:		FOUL DRAINAGE LAYOUT	
Scale:	1:500(A0)	NTS(A3)	
Drawing Register No:	017	Drawing No:	Y17702-PL-017
Rev:			0